


Cavco Homes of Texas reserves the right to make changes at any time in prices, specifications and design without notice and/or obligation. All dimensions and specifications are nominal and subject to change.

All changes required by local regulatory agencies will be the responsibility of the seller/buyer unless properly submitted to the manufacturing facility prior to the order placement and acceptance. All changes will be considered on a case-by-case basis and charged accordingly. Cavco Homes of Texas will not take responsibility for additional requirements without having full knowledge of such at the time the order is placed. All design details and notes are suggestive only and are subject to the jurisdiction of the state and local codes. See local building department for frost line and soil requirements.

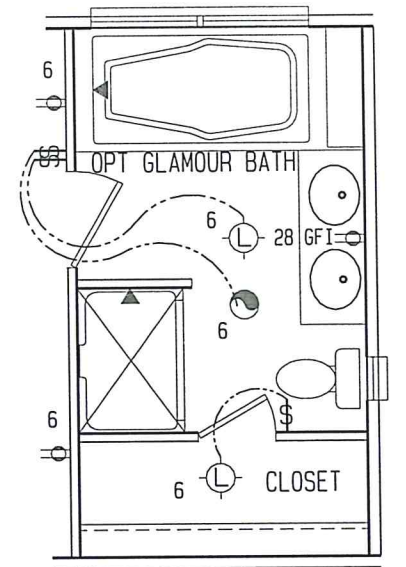

ELECTRICAL SYMBOL LEGEND		
§ -SWITCH	 -MAIN PANEL	-GAS INLET
§ ₃ -3-WAY SWITCH	 -EXHAUST FAN	-DRAIN OUTLET
 -SPEAKER	 -CEILING LIGHT	-ELEC. ENTRANCE
Ⓣ -THERMOSTAT	 -CEILING FAN	-FRESH WATER
 -RECEPT	H.T. -HEAT TAPE	INSIGNIA LOC. & VEHICLE ID LABEL
 -SWITCHED RECEPT	-FIRE EXTIG.	 -TELEPHONE
W.P. -WEATHER PROOF	 -SMOKE DET.	 -TELEVISION


The logo for Caveo Industries Inc. features the word "Caveo" in a large, stylized serif font. Above the letters, there is a graphic of a mountain peak composed of many small, overlapping, curved lines. Below the word "Caveo", the words "INDUSTRIES INC." are written in a smaller, plain, sans-serif font.

COPYRIGHT © 2006

MODEL:	AL16763B	
DESC:	ELECTRICAL PLAN	
DATE:	07/09/13	SCALE: 3/16=1'-0
DRAWN:	F. Ybarra	
REVISIONS		DATE

COLD WATER - STD MASTER BATH ONLY

PLUMBING SCHEDULE		
CODE	QTY	DESCRIPTION
E21	8	ELBOW Red-90, 3/4x1/2
E22	10	ELBOW-90, 3/4x3/4
T221	1	Tee Red 90, 3/4x3/4x1/2
T222	9	Tee 90, 3/4x3/4x3/4

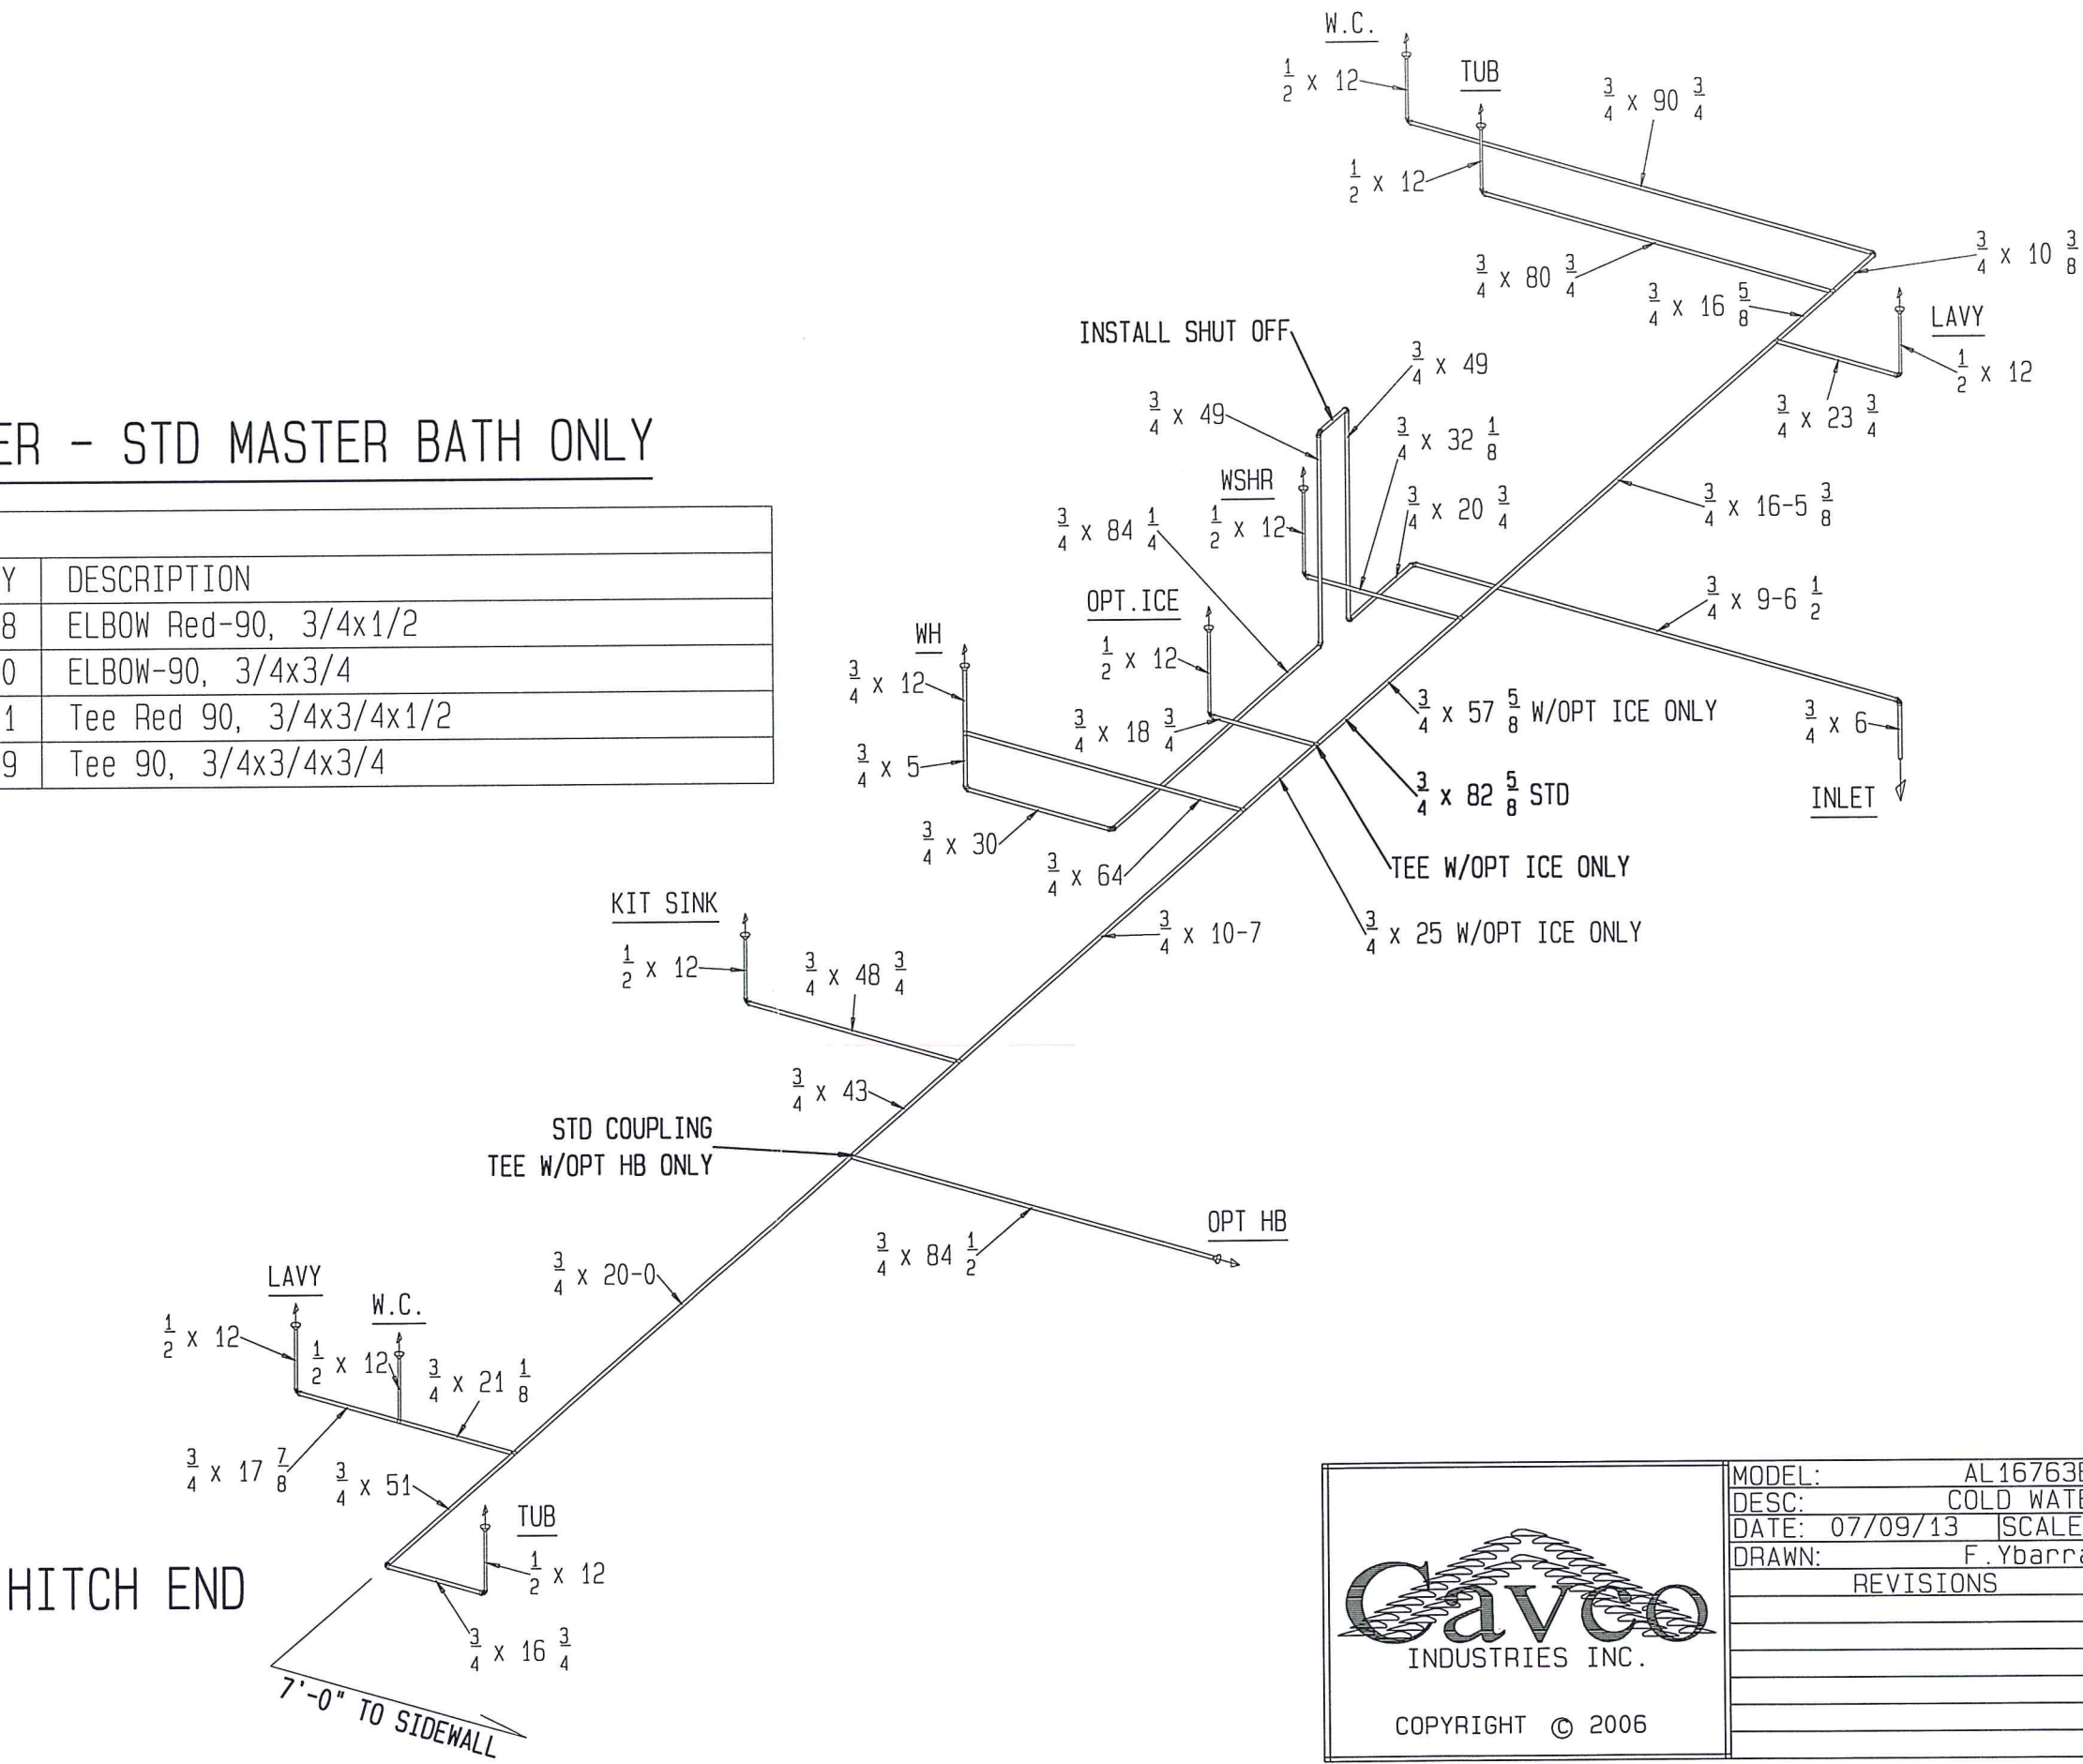

PLEASE NOTE:

Cavco Homes of Texas reserves the right to make changes at any time in prices, specifications and design without notice and/or obligation. All dimensions and specifications are nominal and subject to change.

It is also the responsibility of the Retailer/Builder/Developer/Consumer to verify and submit specs to all regulatory agencies including but not limited to Cities, Counties, protective covenants, etc...prior to ordering the home.

All changes required by local regulatory agencies will be the responsibility of the seller/buyer unless properly submitted to the manufacturing facility prior to the order placement and acceptance. All changes will be considered on a case-by-case basis and charged accordingly. Cavco Homes of Texas will not take responsibility for additional requirements without having full knowledge of such at the time the order is placed. All design details and notes are suggestive only and are subject to the jurisdiction of the state and local codes. See local building department for frost line and soil requirements.




COPYRIGHT © 2006

MODEL:	AL16763B
DESC:	COLD WATER
DATE:	07/09/13
SCALE:	3/16=1'-0
DRAWN:	F.Ybarra
REVISIONS	DATE

COLD WATER - OPT GLAMOUR BATH ONLY

PLUMBING SCHEDULE		
CODE	QTY	DESCRIPTION
E21	8	ELBOW Red-90, 3/4x1/2
E22	10	ELBOW-90, 3/4x3/4
T221	1	Tee Red 90, 3/4x3/4x1/2
T222	9	Tee 90, 3/4x3/4x3/4

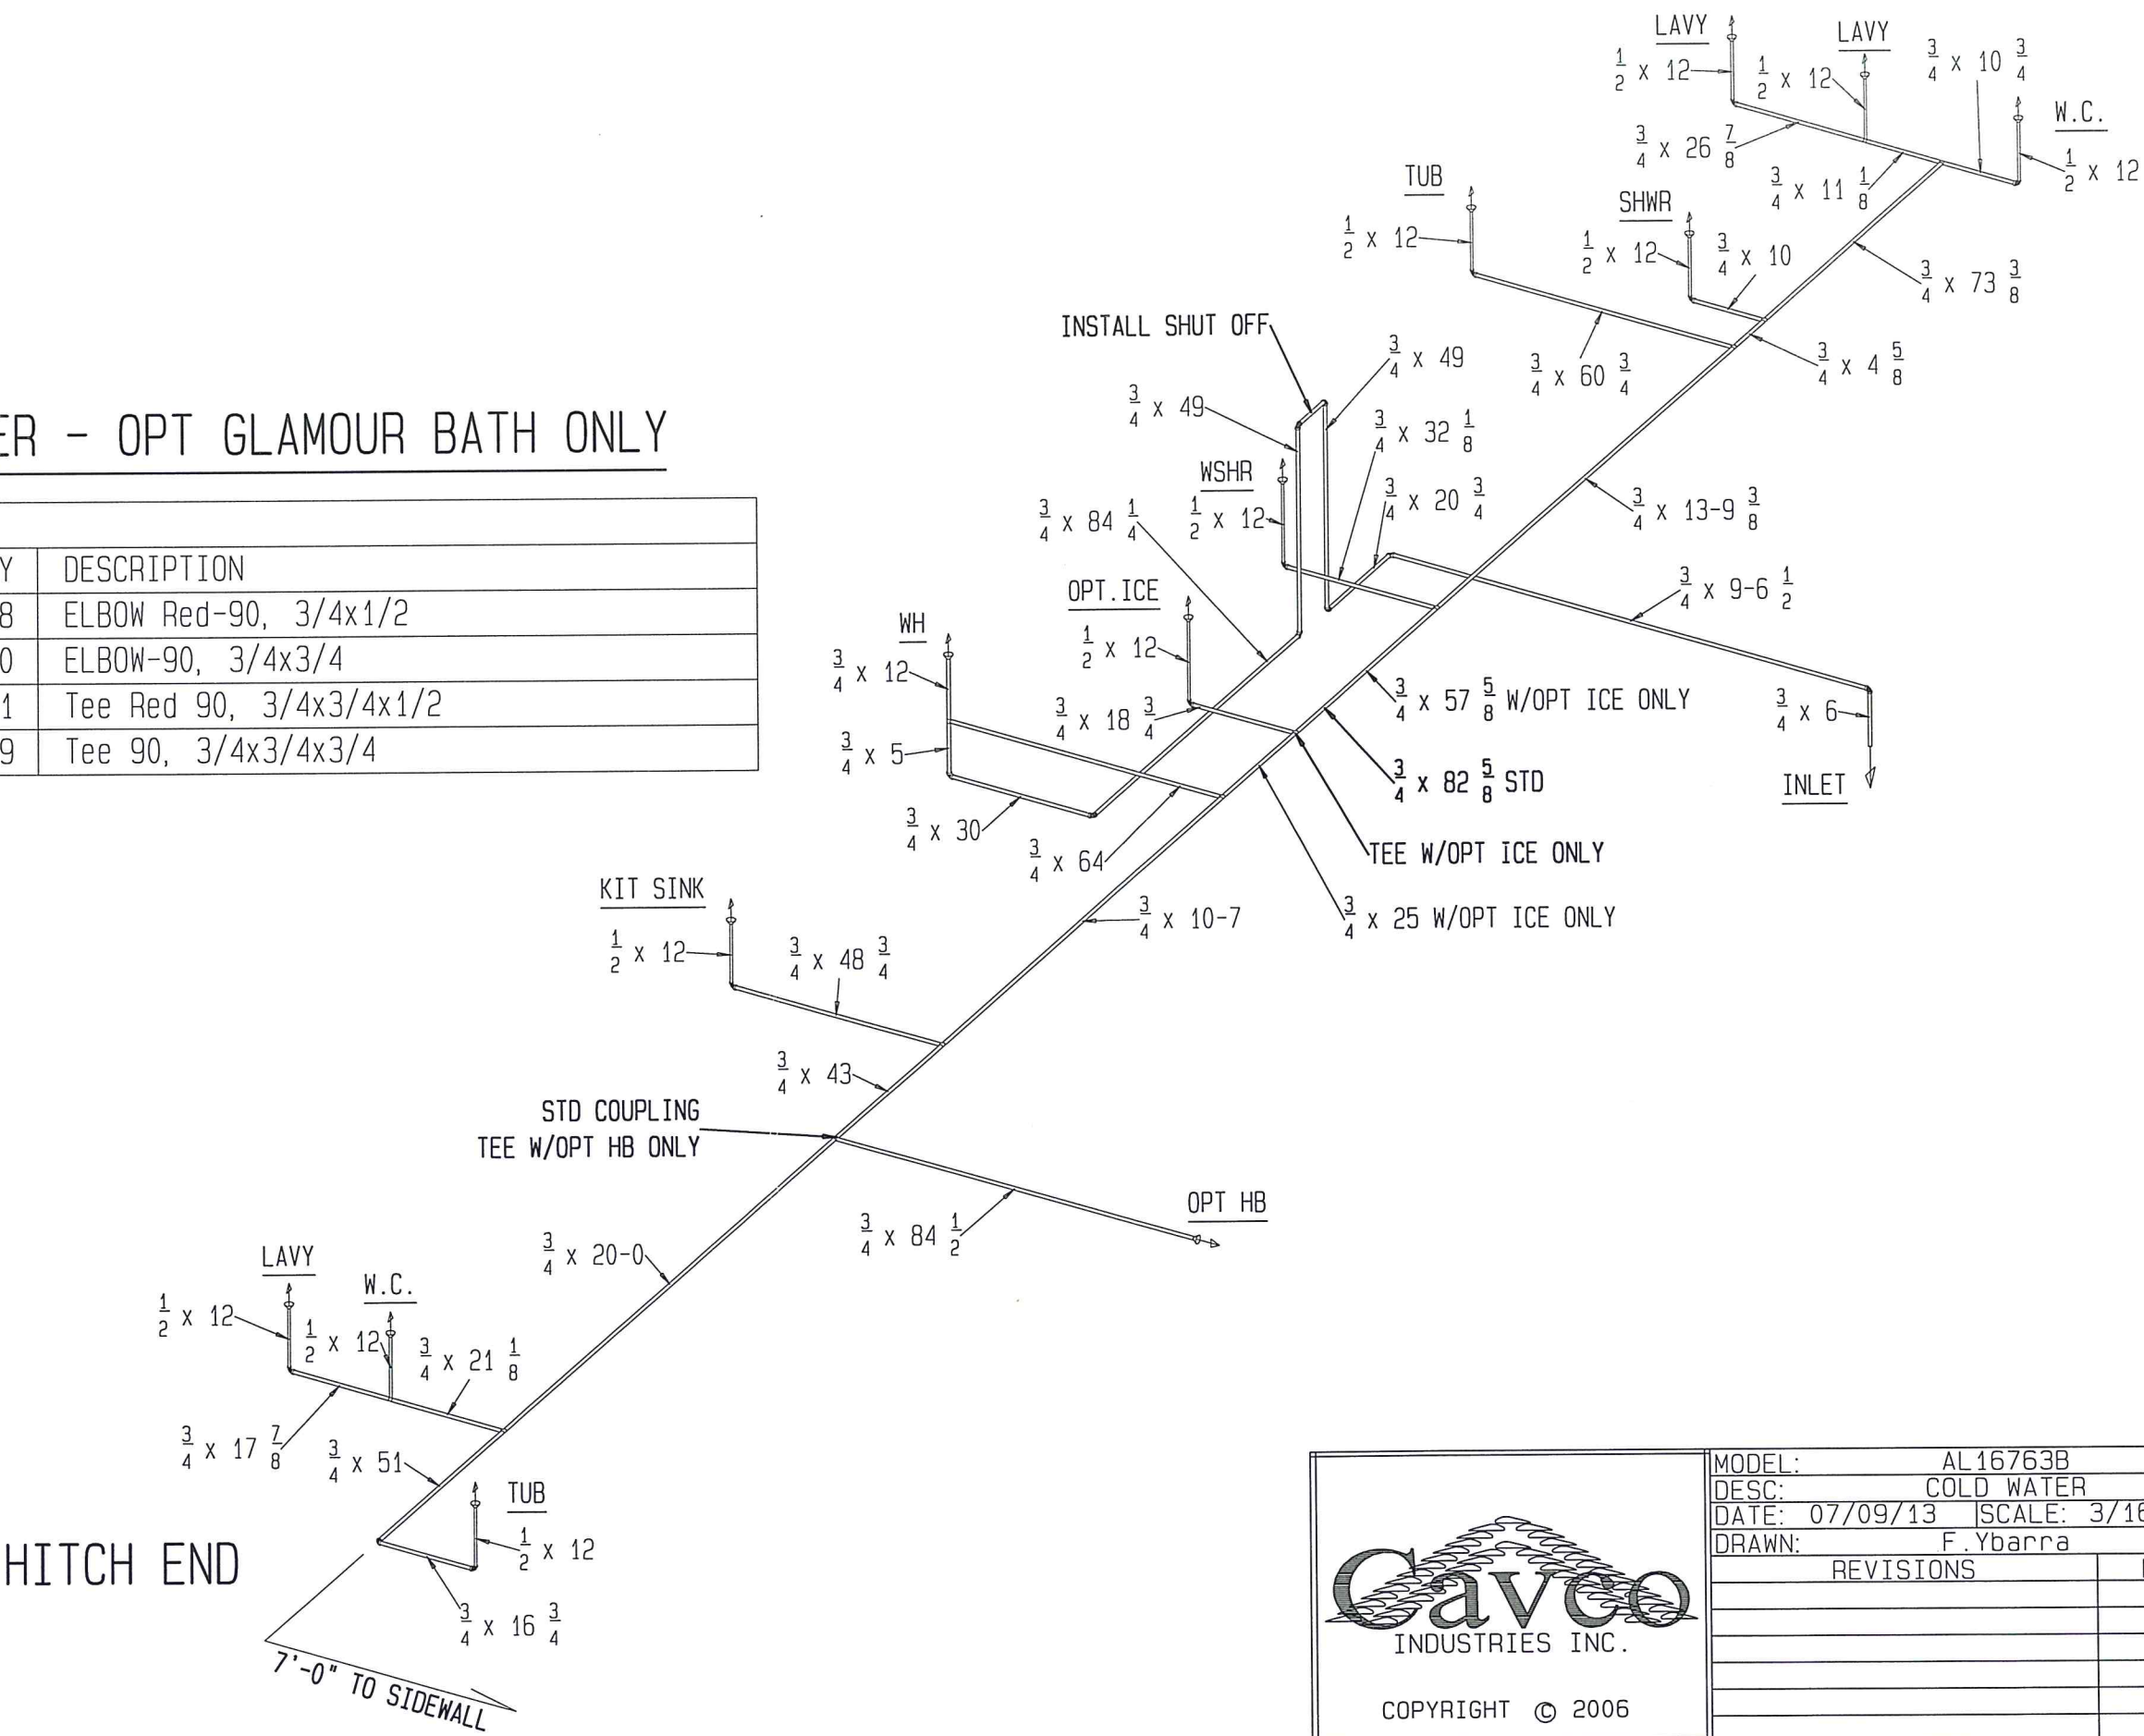

PLEASE NOTE:
Cavco Homes of Texas reserves the right to make changes at any time in prices, specifications and design without notice and/or obligation. All dimensions and specifications are nominal and subject to change.
It is also the responsibility of the Retailer/Builder/Developer/Consumer to verify and submit specs to all regulatory agencies including but not limited to Cities, Counties, protective covenants, etc...prior to ordering the home.
All changes required by local regulatory agencies will be the responsibility of the seller/buyer unless properly submitted to the manufacturing facility prior to the order placement and acceptance. All changes will be considered on a case-by-case basis and charged accordingly. Cavco Homes of Texas will not take responsibility for additional requirements without having full knowledge of such at the time the order is placed. All design details and notes are suggestive only and are subject to the jurisdiction of the state and local codes. See local building department for frost line and soil requirements.



COPYRIGHT © 2006

MODEL:	AL16763B	
DESC:	COLD WATER	
DATE:	07/09/13	SCALE: 3/16=1'-0
DRAWN:	F.Ybarra	
REVISIONS		DATE

HOT WATER - STD MASTER BATH ONLY


PLUMBING SCHEDULE		
CODE	QTY	DESCRIPTION
C22	1	COUPLING 3/4
E21	6	ELBOW Red-90, 3/4x1/2
E22	2	ELBOW-90, 3/4x3/4
T222	6	Tee 90, 3/4x3/4x3/4

HITCH END

PLEASE NOTE:

Cavco Homes of Texas reserves the right to make changes at any time in prices, specifications and design without notice and/or obligation. All dimensions and specifications are nominal and subject to change. It is also the responsibility of the Retailer/Builder/Developer/Consumer to verify and submit specs to all regulatory agencies including but not limited to Cities, Counties, protective covenants, etc...prior to ordering the home.

All changes required by local regulatory agencies will be the responsibility of the seller/buyer unless properly submitted to the manufacturing facility prior to the order placement and acceptance. All changes will be considered on a case-by-case basis and charged accordingly. Cavco Homes of Texas will not take responsibility for additional requirements without having full knowledge of such at the time the order is placed. All design details and notes are suggestive only and are subject to the jurisdiction of the state and local codes. See local building department for frost line and soil requirements.

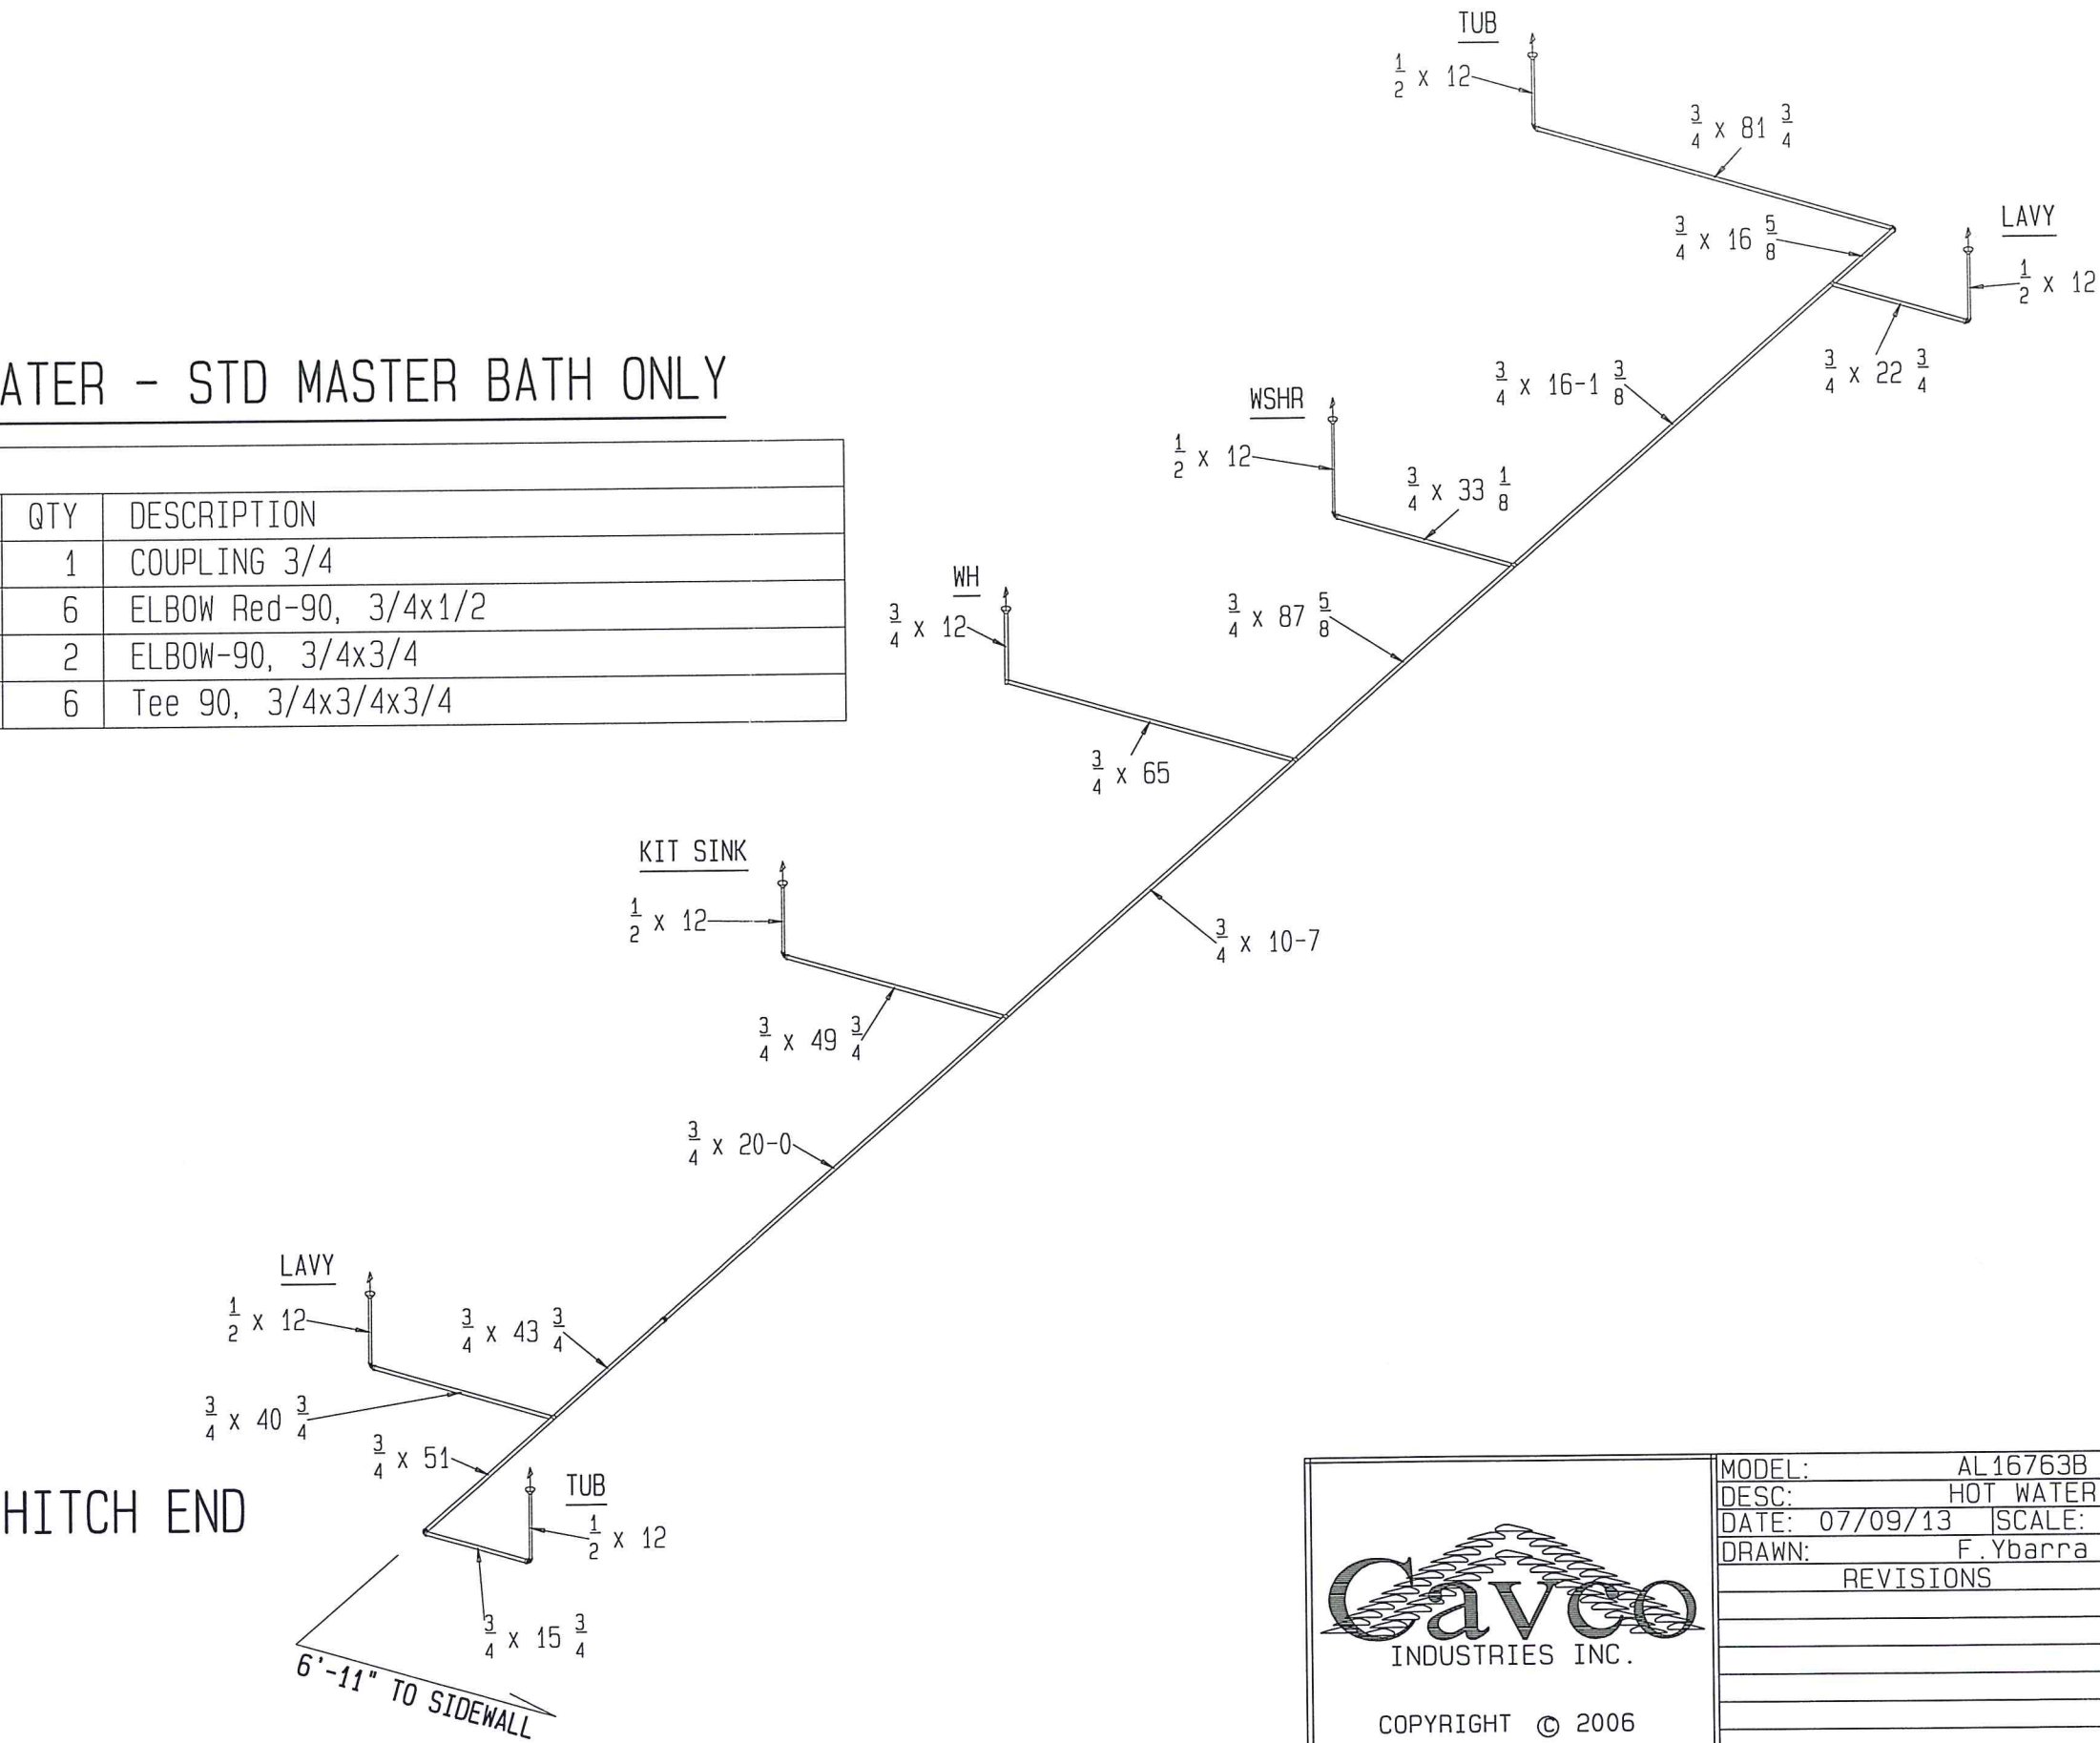



COPYRIGHT © 2006

MODEL:	AL16763B
DESC:	HOT WATER
DATE:	07/09/13
SCALE:	3/16=1'-0
DRAWN:	F.Ybarra
REVISIONS	DATE

HOT WATER - OPT GLAMOUR BATH ONLY

PLUMBING SCHEDULE		
CODE	QTY	DESCRIPTION
C22	1	COUPLING 3/4
E21	6	ELBOW Red-90, 3/4x1/2
E22	2	ELBOW-90, 3/4x3/4
T222	6	Tee 90, 3/4x3/4x3/4


PLEASE NOTE:

Cavco Homes of Texas reserves the right to make changes at any time in prices, specifications and design without notice and/or obligation. All dimensions and specifications are nominal and subject to change. It is also the responsibility of the Retailer/Builder/Developer/Consumer to verify and submit specs to all regulatory agencies including but not limited to Cities, Counties, protective covenants, etc...prior to ordering the home.

All changes required by local regulatory agencies will be the responsibility of the seller/buyer unless properly submitted to the manufacturing facility prior to the order placement and acceptance. All changes will be considered on a case-by-case basis and charged accordingly. Cavco Homes of Texas will not take responsibility for additional requirements without having full knowledge of such at the time the order is placed. All design details and notes are suggestive only and are subject to the jurisdiction of the state and local codes. See local building department for frost line and soil requirements.

HITCH END

6'-11" TO SIDEWALL


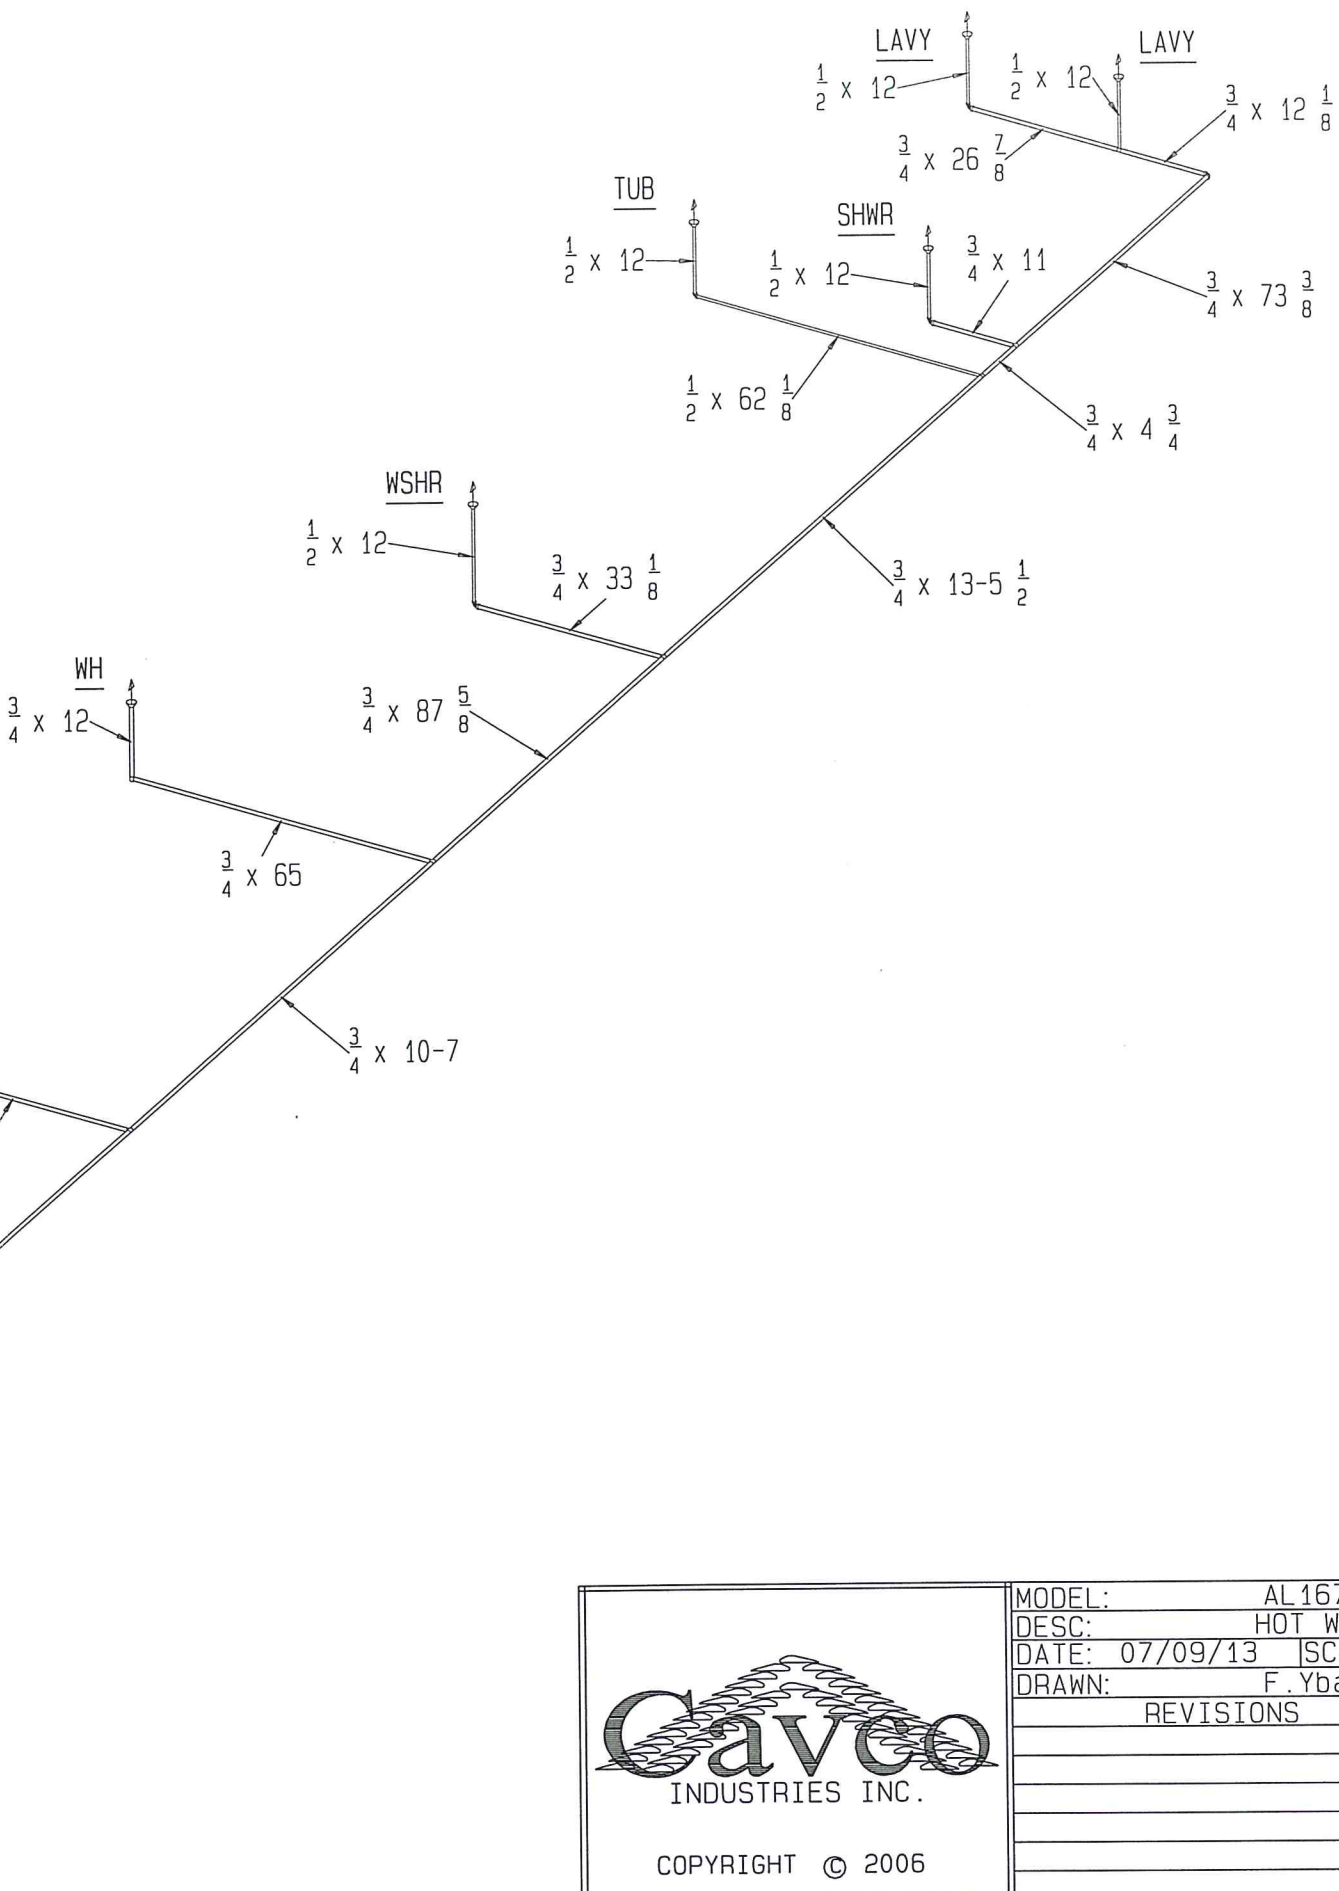


COPYRIGHT © 2006

MODEL:	AL16763B
DESC:	HOT WATER
DATE:	07/09/13
SCALE:	3/16=1'-0
DRAWN:	F.Ybarra
REVISIONS	DATE

DRAIN LINE - STD MASTER BATH ONLY

PLUMBING SCHEDULE		
CODE	QTY	DESCRIPTION
D-E-22-1	1	ELBOW (22-1/2) 1-1/2
D-E-22-2	2	ELBOW (22-1/2) 2
D-E-22-3	2	ELBOW (22-1/2) 3
D-EL-90-1	5	ELBOW (90-LONG) 1-1/2
D-EL-90-2	3	ELBOW (90-LONG) 2
D-EL-90-3	1	ELBOW (90-LONG) 3
D-ST-90-3	1	ELBOW (90-SHORT) 3
D-LTTY-222	1	T-WYE (LONG-TURN) 2 x 2 x 2
D-LTTY-323	1	T-WYE (LONG-TURN) 3 W/FL.BUSH.
D-LTTY-331	4	T-WYE (LONG-TURN) 3 x 3 x 1-1/2
D-LTTY-332	1	T-WYE (LONG-TURN) 3 x 3 x 2
D-ST-1.5	4	SAN TEE 1-1/2
D-ST-2-1.5-1.5	2	SAN TEE 2 x 1-1/2 x 1-1/2
DWV-26	1	ELBOW (90-DOUBLE) 3
DWV-AVENT-1.5	4	AUTO-VENT ASSEMBLY
DWV-CLOSF1-3	2	CLOSET FLANGE ASSEMBLY
DWV-RVENT-1.5	2	ROOF VENT ASSEMBLY
DWV-TRAP-1.5	6	P-TRAP W/UNION 1-1/2
DWW-CO-2	1	CLEAN OUT 2

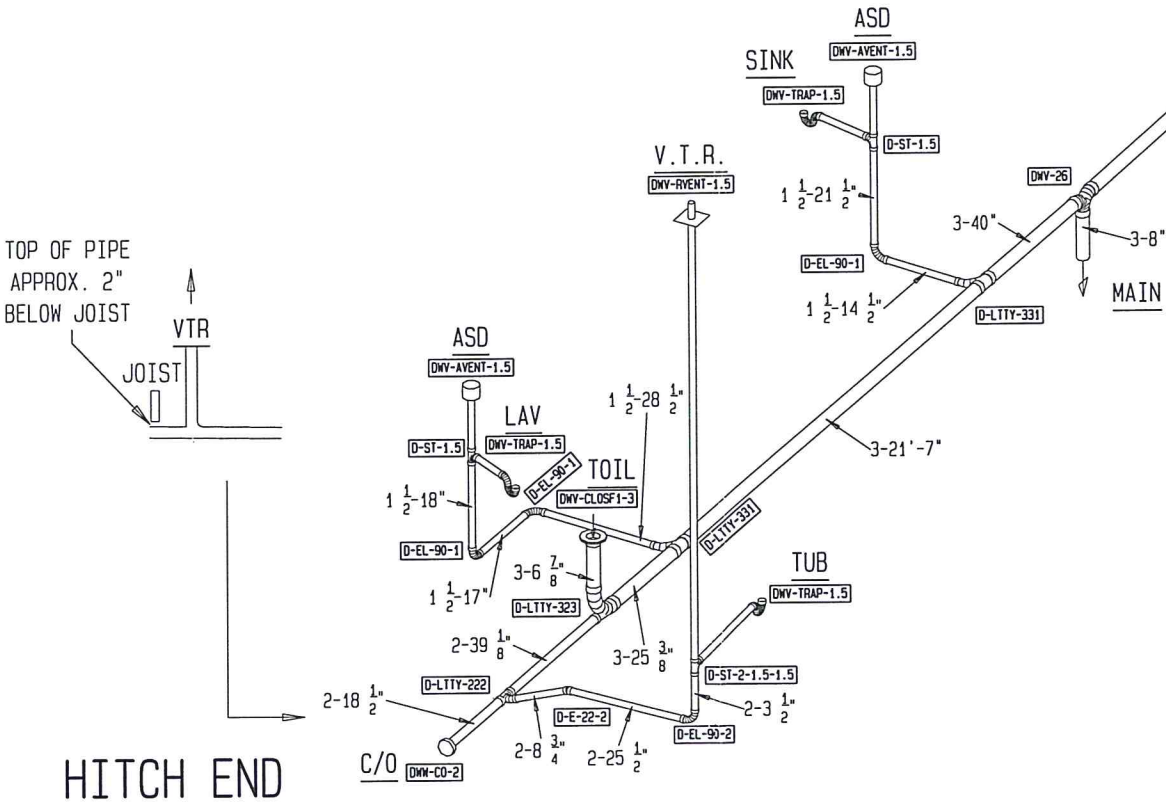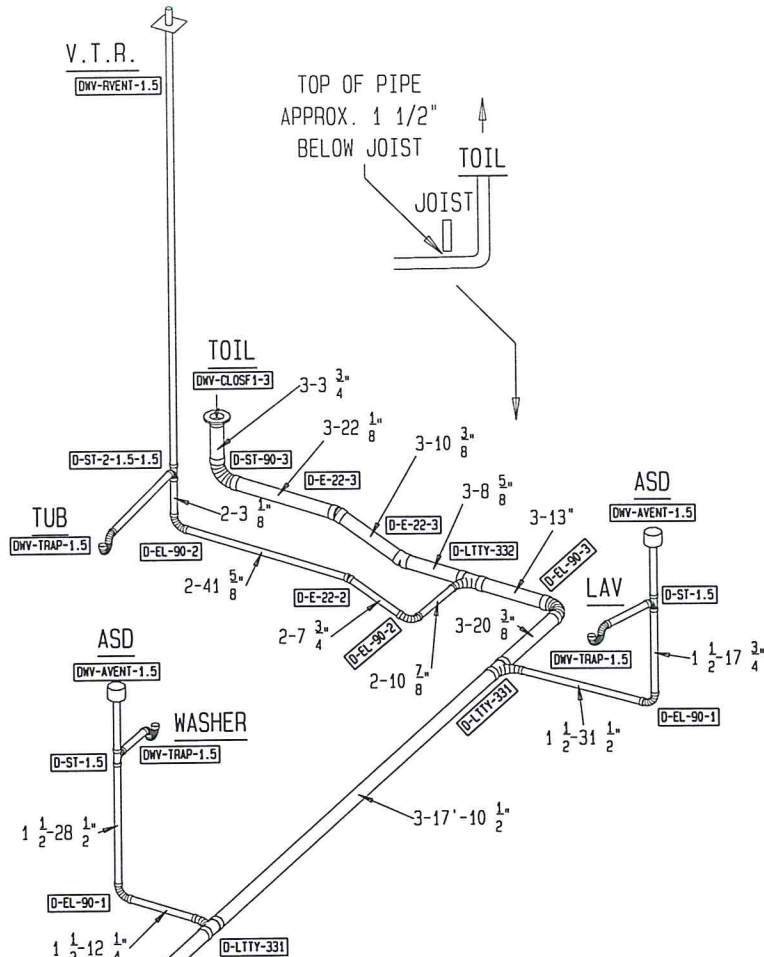

SLOPE: 1/8" PER 1'

PLEASE NOTE:

Cavco Homes of Texas reserves the right to make changes at any time in prices, specifications and design without notice and/or obligation. All dimensions and specifications are nominal and subject to change. It is also the responsibility of the Retailer/Builder/Developer/Consumer to verify and submit specs to all regulatory agencies including but not limited to Cities, Counties, protective covenants, etc...prior to ordering the home. All changes required by local regulatory agencies will be the responsibility of the seller/buyer unless properly submitted to the manufacturing facility prior to the order placement and acceptance. All changes will be considered on a case-by-case basis and charged accordingly. Cavco Homes of Texas will not take responsibility for additional requirements without having full knowledge of such at the time the order is placed. All design details and notes are suggestive only and are subject to the jurisdiction of the state and local codes. See local building department for frost line and soil requirements.




COPYRIGHT © 2006

MODEL:	AL16763B	
DESC:	DRAIN LINE	
DATE:	07/09/13	SCALE: 3/16=1'-0
DRAWN:	F.Ybarra	
REVISIONS		DATE

DRAIN LINE - OPT GLAMOUR BATH ONLY

PLUMBING SCHEDULE		
CODE	QTY	DESCRIPTION
D-E-22-1	1	ELBOW (22-1/2) 1-1/2
D-E-22-2	2	ELBOW (22-1/2) 2
D-E-22-3	2	ELBOW (22-1/2) 3
D-EL-90-1	5	ELBOW (90-LONG) 1-1/2
D-EL-90-2	3	ELBOW (90-LONG) 2
D-EL-90-3	1	ELBOW (90-LONG) 3
D-ST-90-3	1	ELBOW (90-SHORT) 3
D-LTTY-222	1	T-WYE (LONG-TURN) 2 x 2 x 2
D-LTTY-323	1	T-WYE (LONG-TURN) 3 W/FL.BUSH.
D-LTTY-331	4	T-WYE (LONG-TURN) 3 x 3 x 1-1/2
D-LTTY-332	1	T-WYE (LONG-TURN) 3 x 3 x 2
D-ST-1.5	4	SAN TEE 1-1/2
D-ST-2-1.5-1.5	2	SAN TEE 2 x 1-1/2 x 1-1/2
DWV-26	1	ELBOW (90-DOUBLE) 3
DWV-AVENT-1.5	4	AUTO-VENT ASSEMBLY
DWV-CLOSF1-3	2	CLOSET FLANGE ASSEMBLY
DWV-RVENT-1.5	2	ROOF VENT ASSEMBLY
DWV-TRAP-1.5	6	P-TRAP W/UNION 1-1/2
DWW-CO-2	1	CLEAN OUT 2

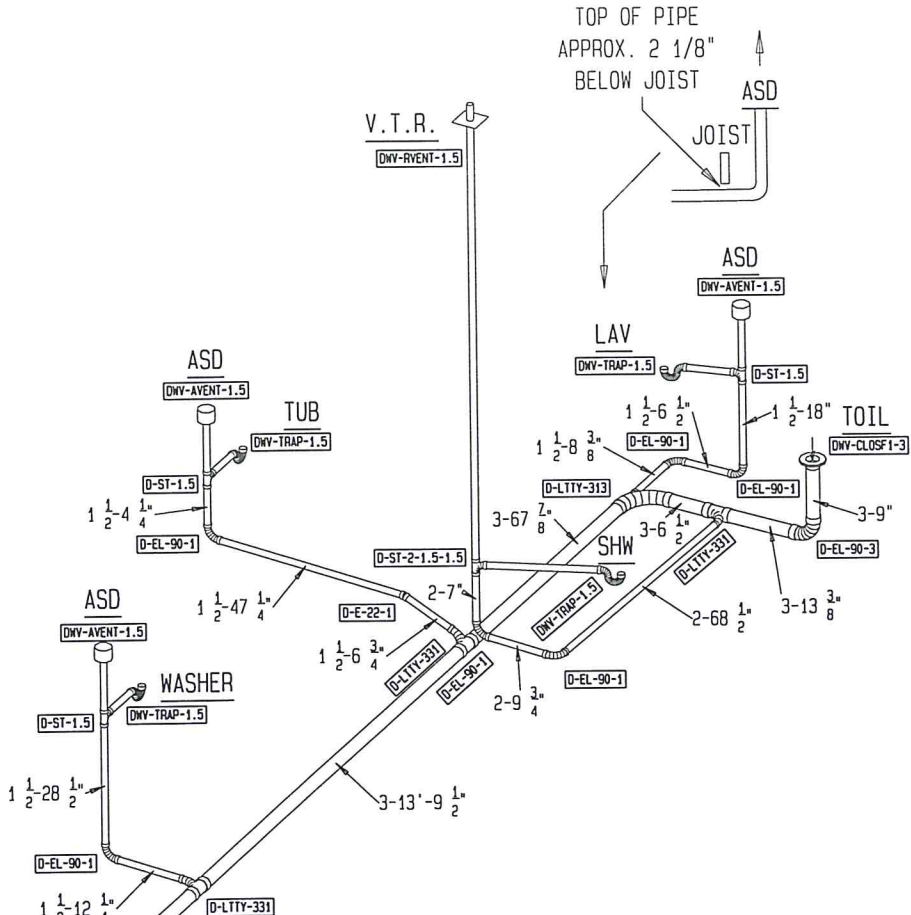


PLEASE NOTE:

Cavco Homes of Texas reserves the right to make changes at any time in prices, specifications and design without notice and/or obligation. All dimensions and specifications are nominal and subject to change.

It is also the responsibility of the Retailer/Builder/Developer/Consumer to verify and submit specs to all regulatory agencies including but not limited to Cities, Counties, protective covenants, etc...prior to ordering the home.

All changes required by local regulatory agencies will be the responsibility of the seller/buyer unless properly submitted to the manufacturing facility prior to the order placement and acceptance. All changes will be considered on a case-by-case basis and charged accordingly. Cavco Homes of Texas will not take responsibility for additional requirements without having full knowledge of such at the time the order is placed. All design details and notes are suggestive only and are subject to the jurisdiction of the state and local codes. See local building department for frost line and soil requirements.

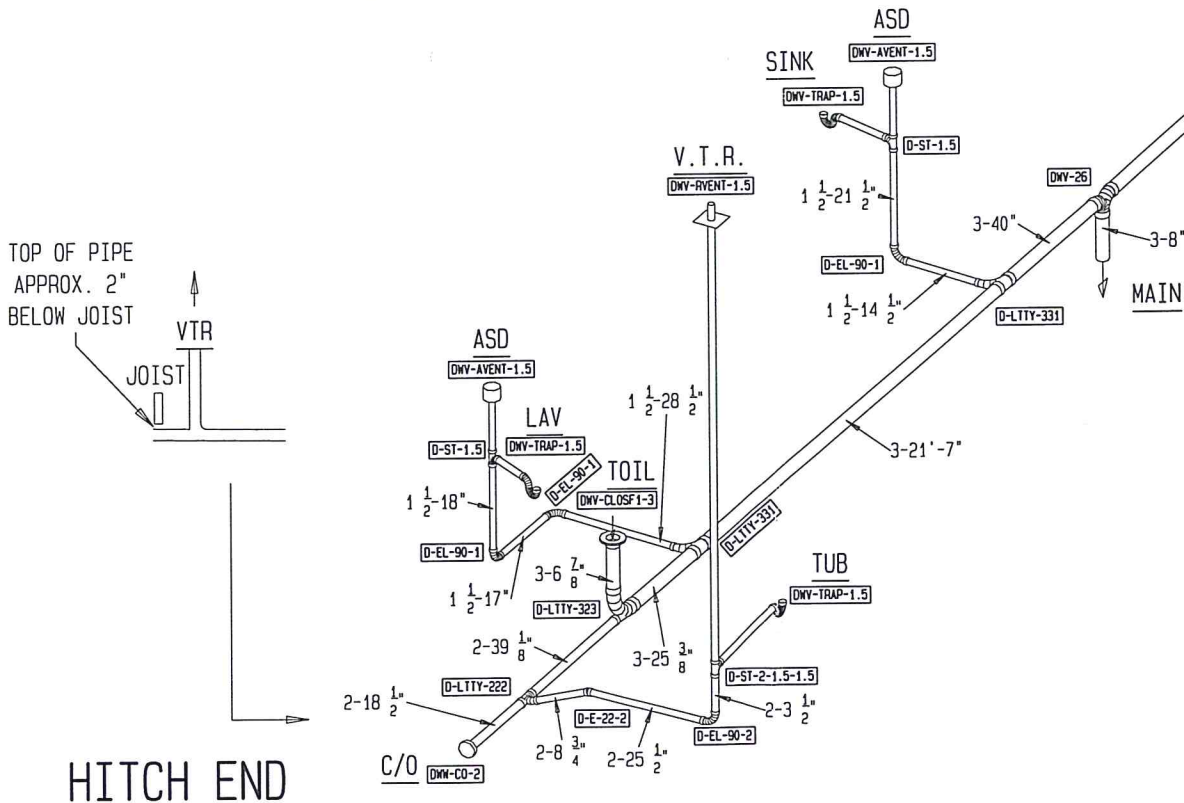


SLOPE: 1/8" PER 1'



COPYRIGHT © 2006

MODEL:	AL16763B	
DESC:	DRAIN LINE	
DATE: 07/09/13	SCALE: 3/16=1'-0	
DRAWN:	F.Ybarra	
REVISIONS		DATE

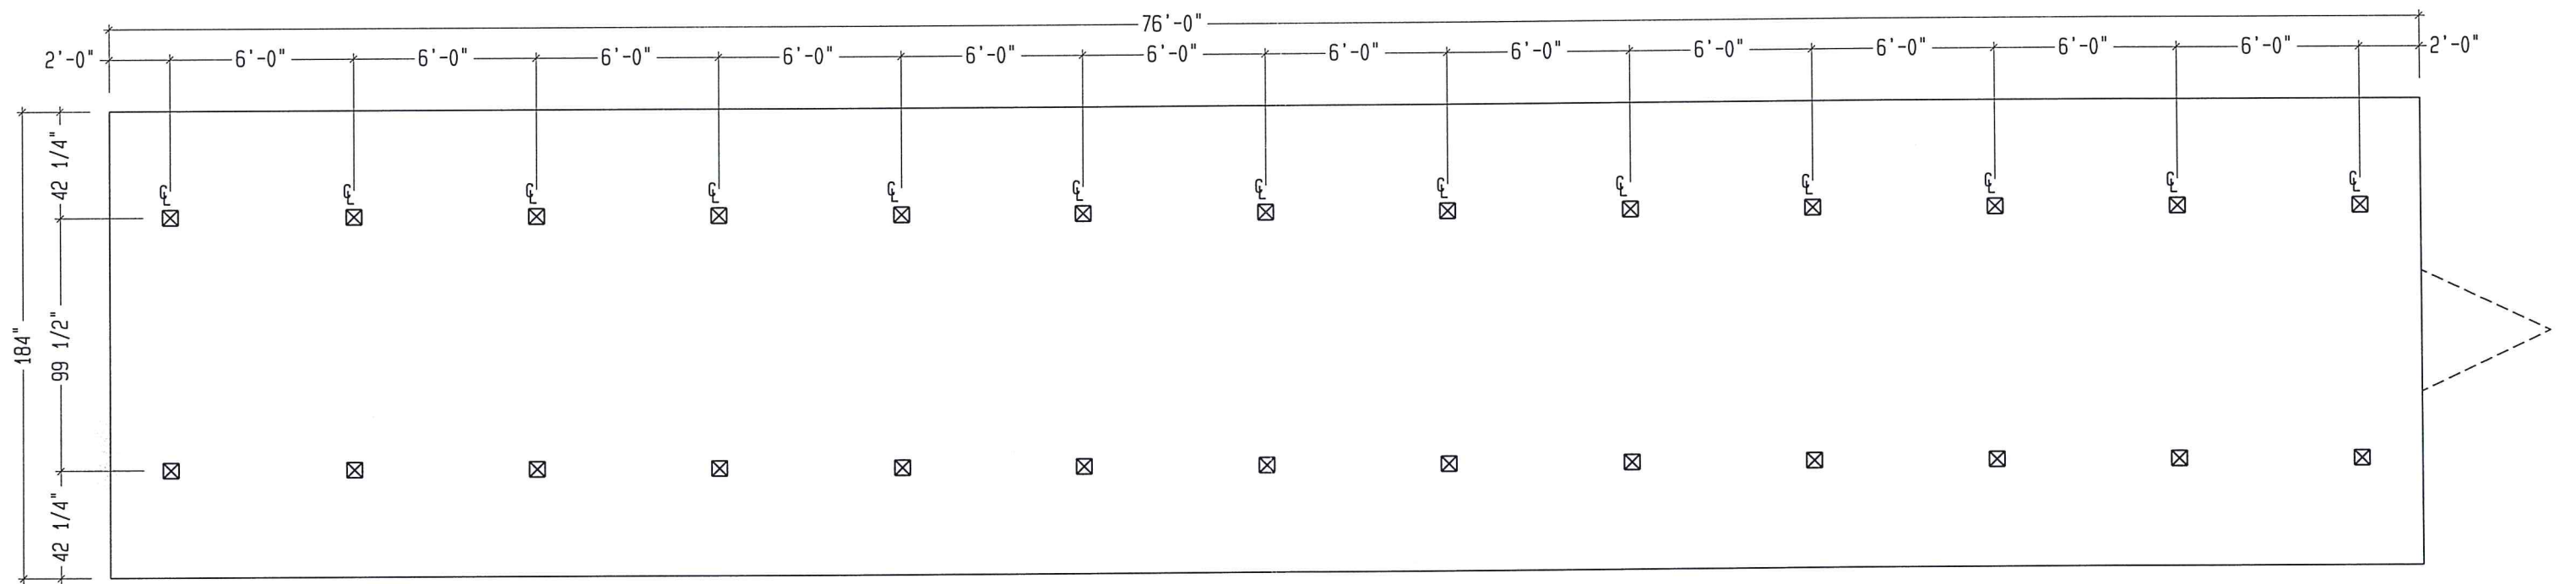

☒ - FRAME PIER SUPPORT

20 LB. ROOF LOAD ONLY

 COPYRIGHT © 2006	MODEL: AL16763B	
	DESC: PIER LOCATIONS	
	DATE: 09/19/11	SCALE: 3/16=1'-0
	DRAWN: F. Ybarra	
	REVISIONS	DATE